



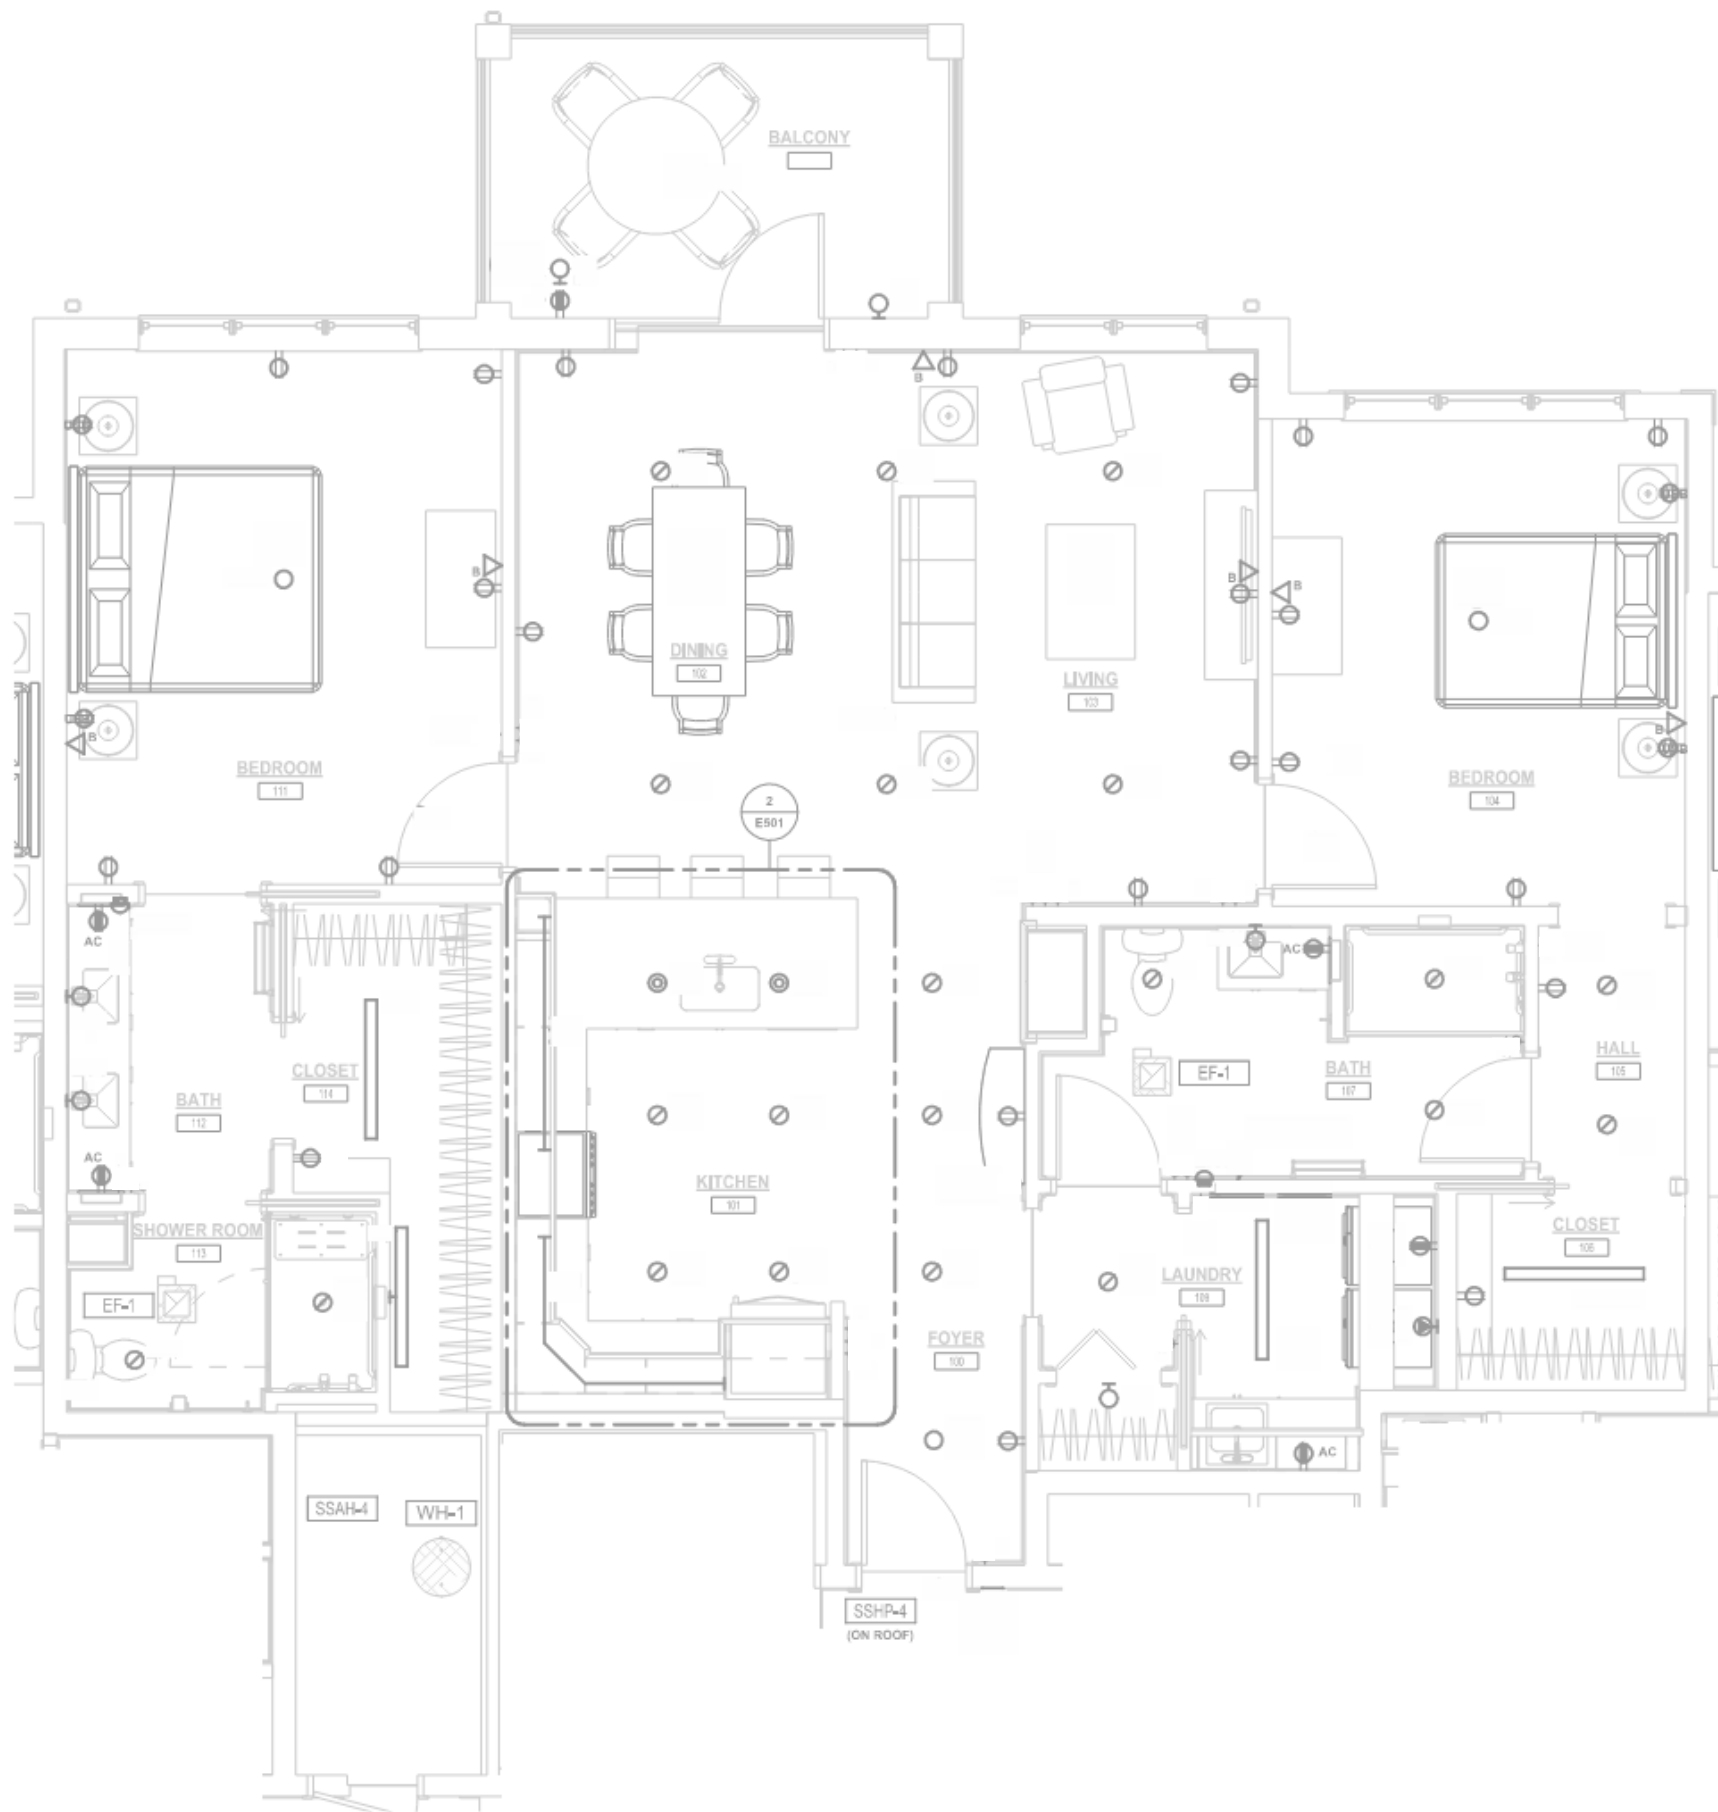

1
E501

ENLARGED 'BLUEBIRD' UNIT ELECTRICAL PLAN

SCALE: 1/4" = 1'-0"

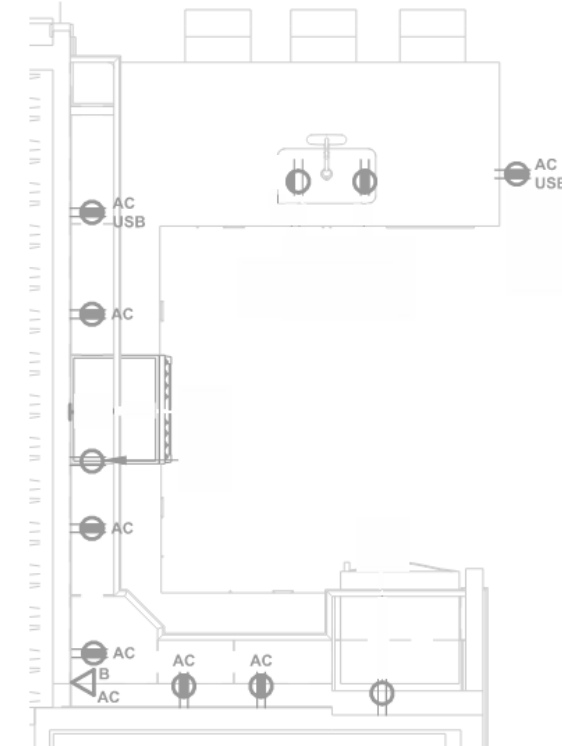

2
E501

ENLARGED 'BLUEBIRD' UNIT KITCHEN POWER PLAN

SCALE: 1/4" = 1'-0"

AC



ABOVE COUNTER

IN-FLOOR DUPLEX RECEPTACLE

SPECIAL PURPOSE RECEPTACLE

DUPLEX RECEPTACLE

GFCI PROTECTED DUPLEX RECEPTACLE

TELECOMMUNICATIONS OUTLET

WALL MOUNT LUMINAIRE

DOUBLE DUPLEX RECEPTACLE

CEILING LUMINAIRE - SURFACE MOUNT

CEILING LUMINAIRE - RECESS MOUNT

PENDANT MOUNT LUMINAIRE

NIGHT-LIGHT LUMINAIRE