



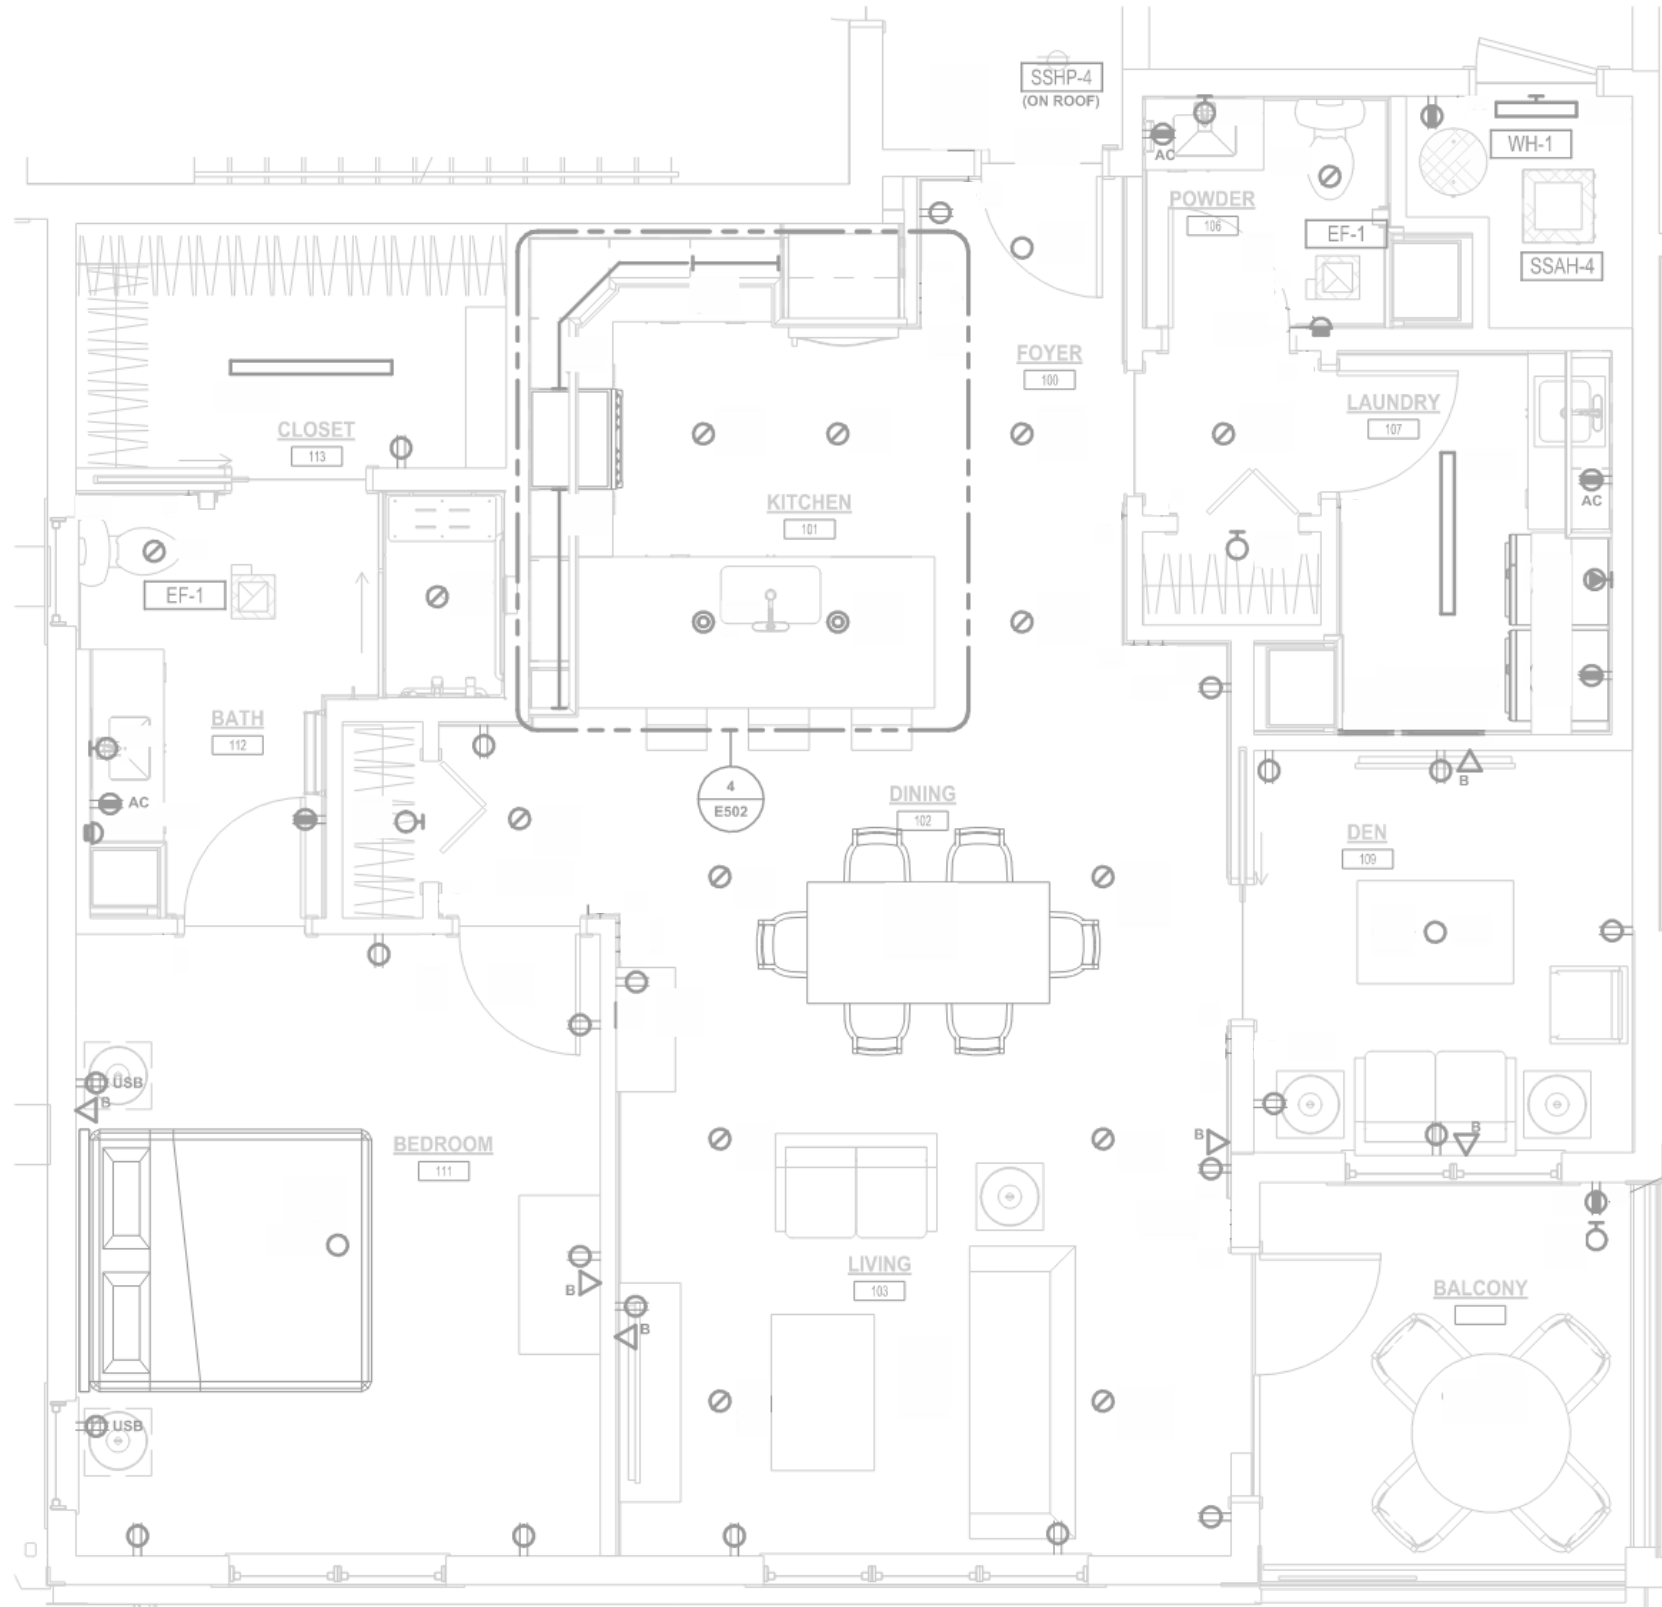

3
E502

ENLARGED 'CHICKADEE' UNIT ELECTRICAL PLAN

SCALE: 1/4" = 1'-0"

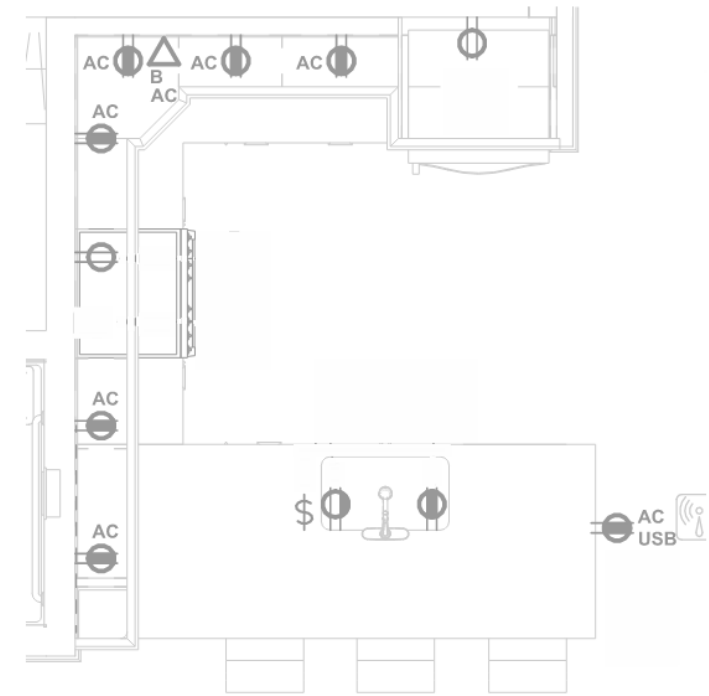

4
E502

ENLARGED 'CHICKADEE' UNIT KITCHEN POWER PLAN

SCALE: 1/4" = 1'-0"

- | | |
|----|-----------------------------------|
| AC | ABOVE COUNTER |
| | IN-FLOOR DUPLEX RECEPTACLE |
| | SPECIAL PURPOSE RECEPTACLE |
| | DUPLEX RECEPTACLE |
| | GFCI PROTECTED DUPLEX RECEPTACLE |
| | TELECOMMUNICATIONS OUTLET |
| | WALL MOUNT LUMINAIRE |
| | DOUBLE DUPLEX RECEPTACLE |
| | CEILING LUMINAIRE - SURFACE MOUNT |
| | CEILING LUMINAIRE - RECESS MOUNT |
| | PENDANT MOUNT LUMINAIRE |
| | NIGHT-LIGHT LUMINAIRE |