


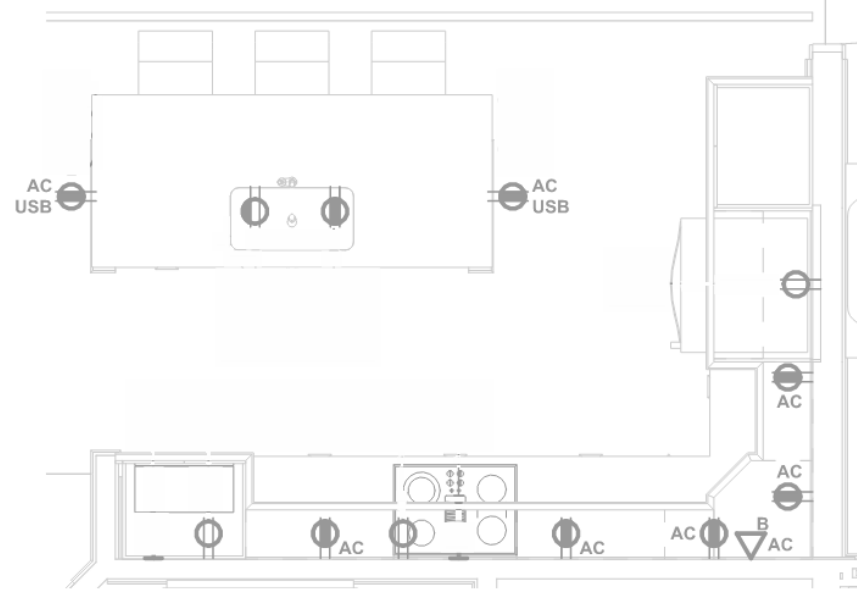

ENLARGED 'GOLDFINCH' UNIT KITCHEN POWER PLAN

4

E501

SCALE: 1/4" = 1'-0"

AC



ABOVE COUNTER



IN-FLOOR DUPLEX RECEPTACLE



SPECIAL PURPOSE RECEPTACLE



DUPLEX RECEPTACLE



GFCI PROTECTED DUPLEX RECEPTACLE



TELECOMMUNICATIONS OUTLET



WALL MOUNT LUMINAIRE



DOUBLE DUPLEX RECEPTACLE



CEILING LUMINAIRE - SURFACE MOUNT




CEILING LUMINAIRE - RECESS MOUNT



PENDANT MOUNT LUMINAIRE



NIGHT-LIGHT LUMINAIRE

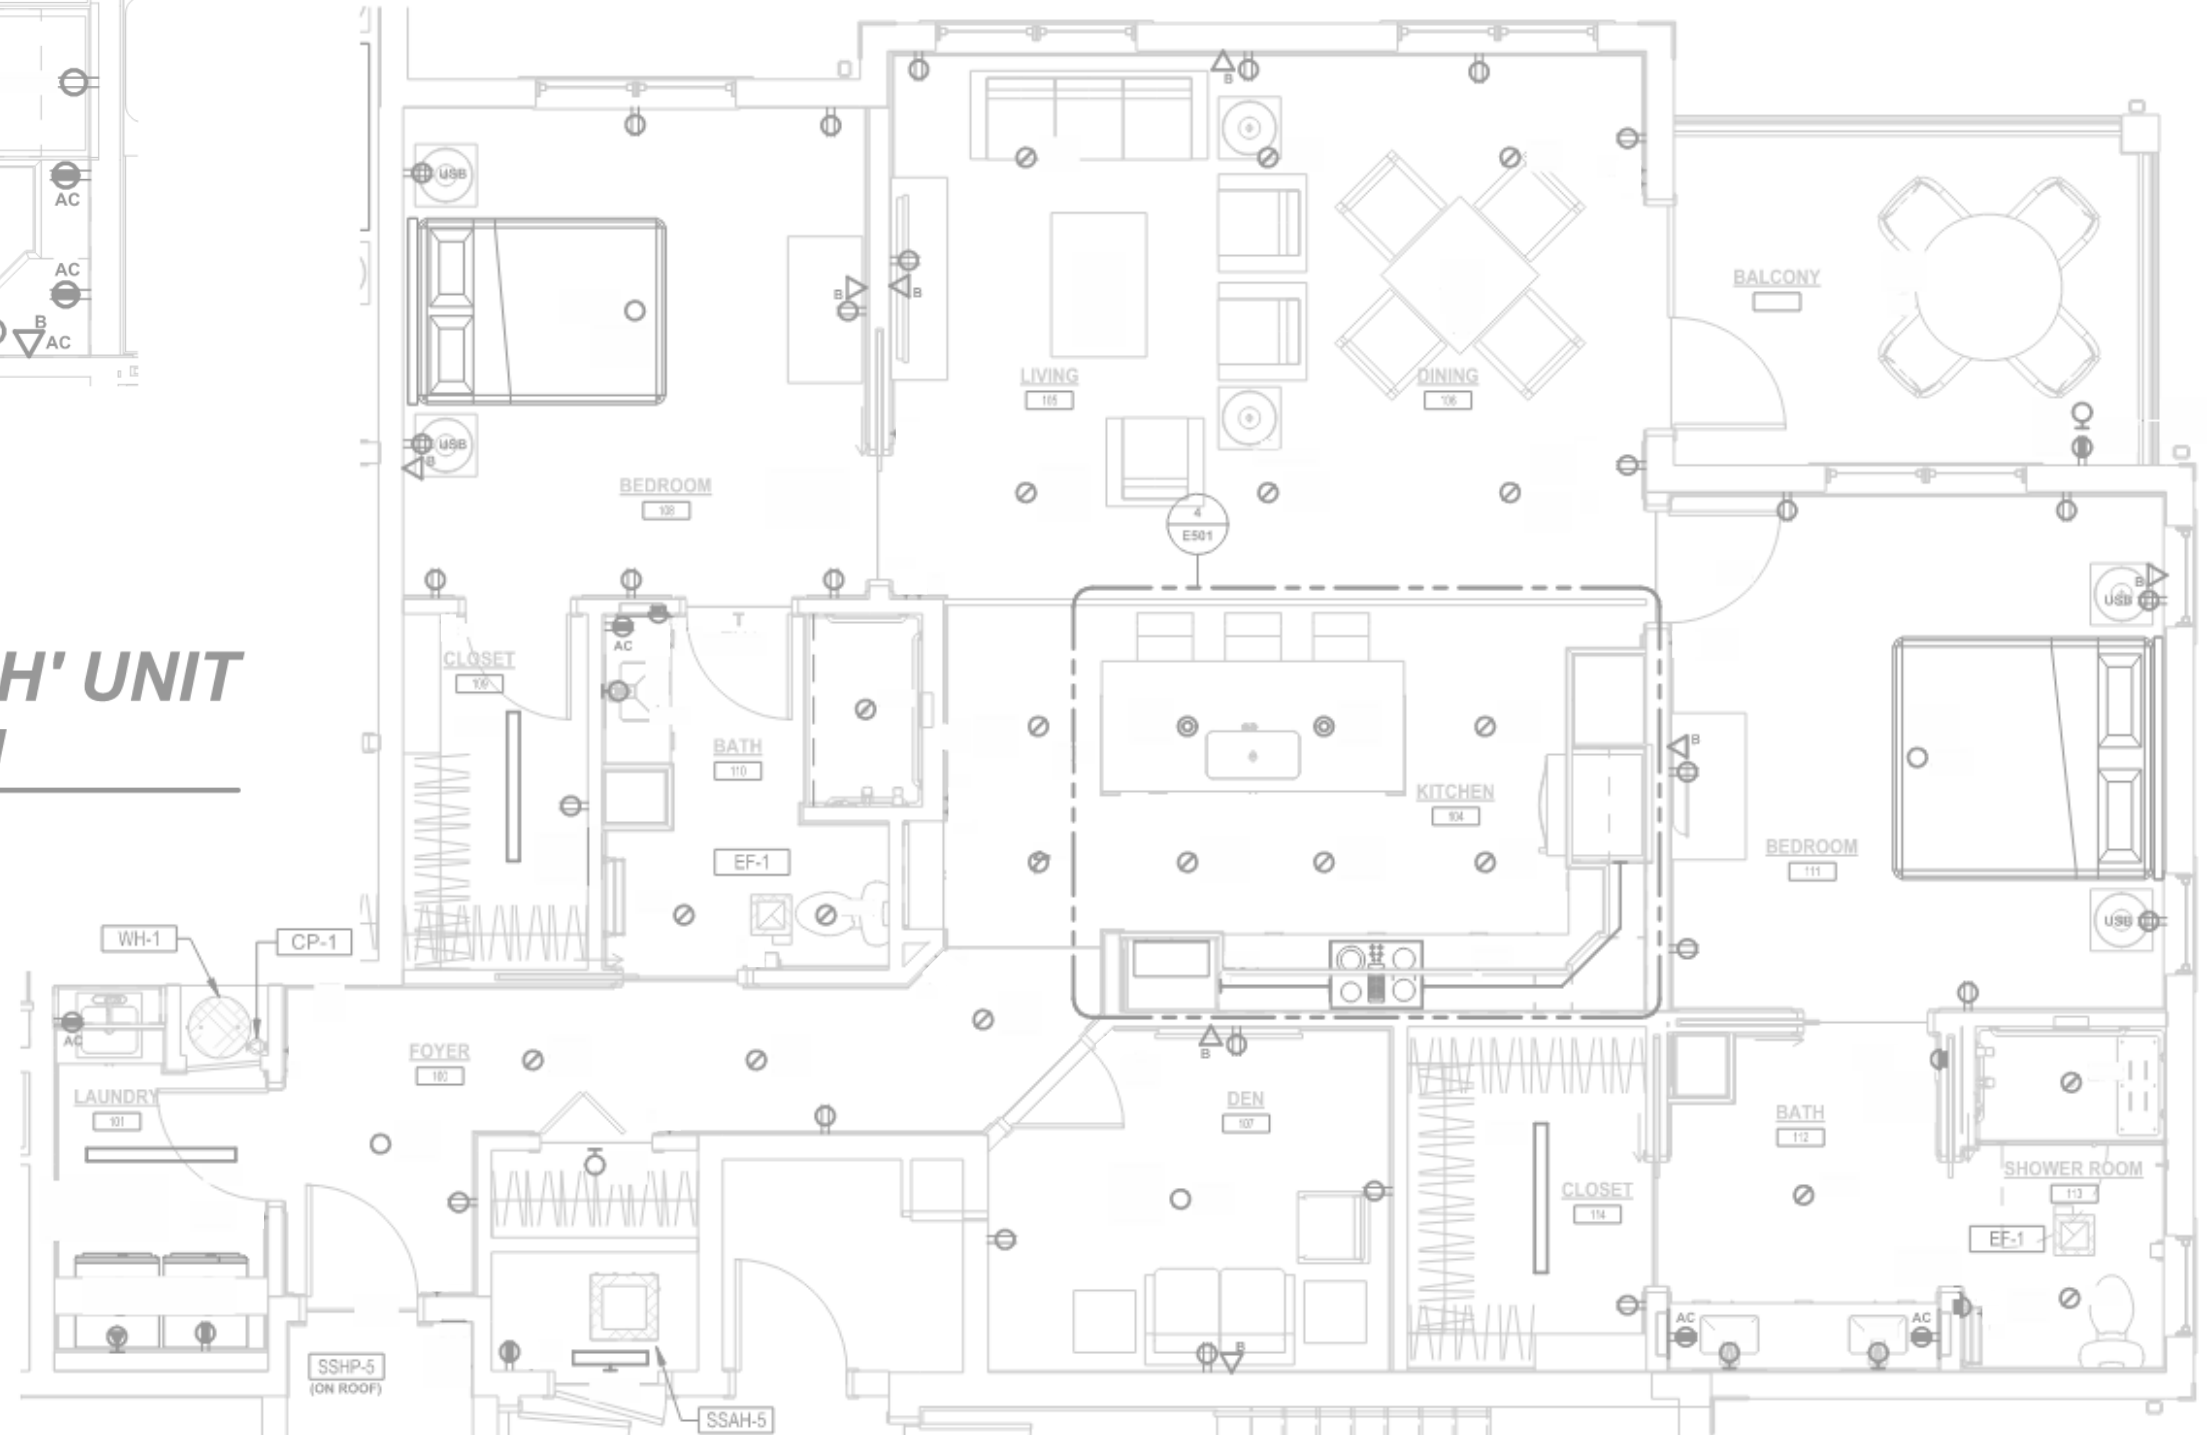

3

E501

ENLARGED 'GOLDFINCH' UNIT ELECTRICAL PLAN

SCALE: 1/4" = 1'-0"